


Drawing Name: Z:\103.0301 - Sheffield Apartments\103.0301 - Site Plan.dwg Date Printed: May 01, 2026, 11:37am

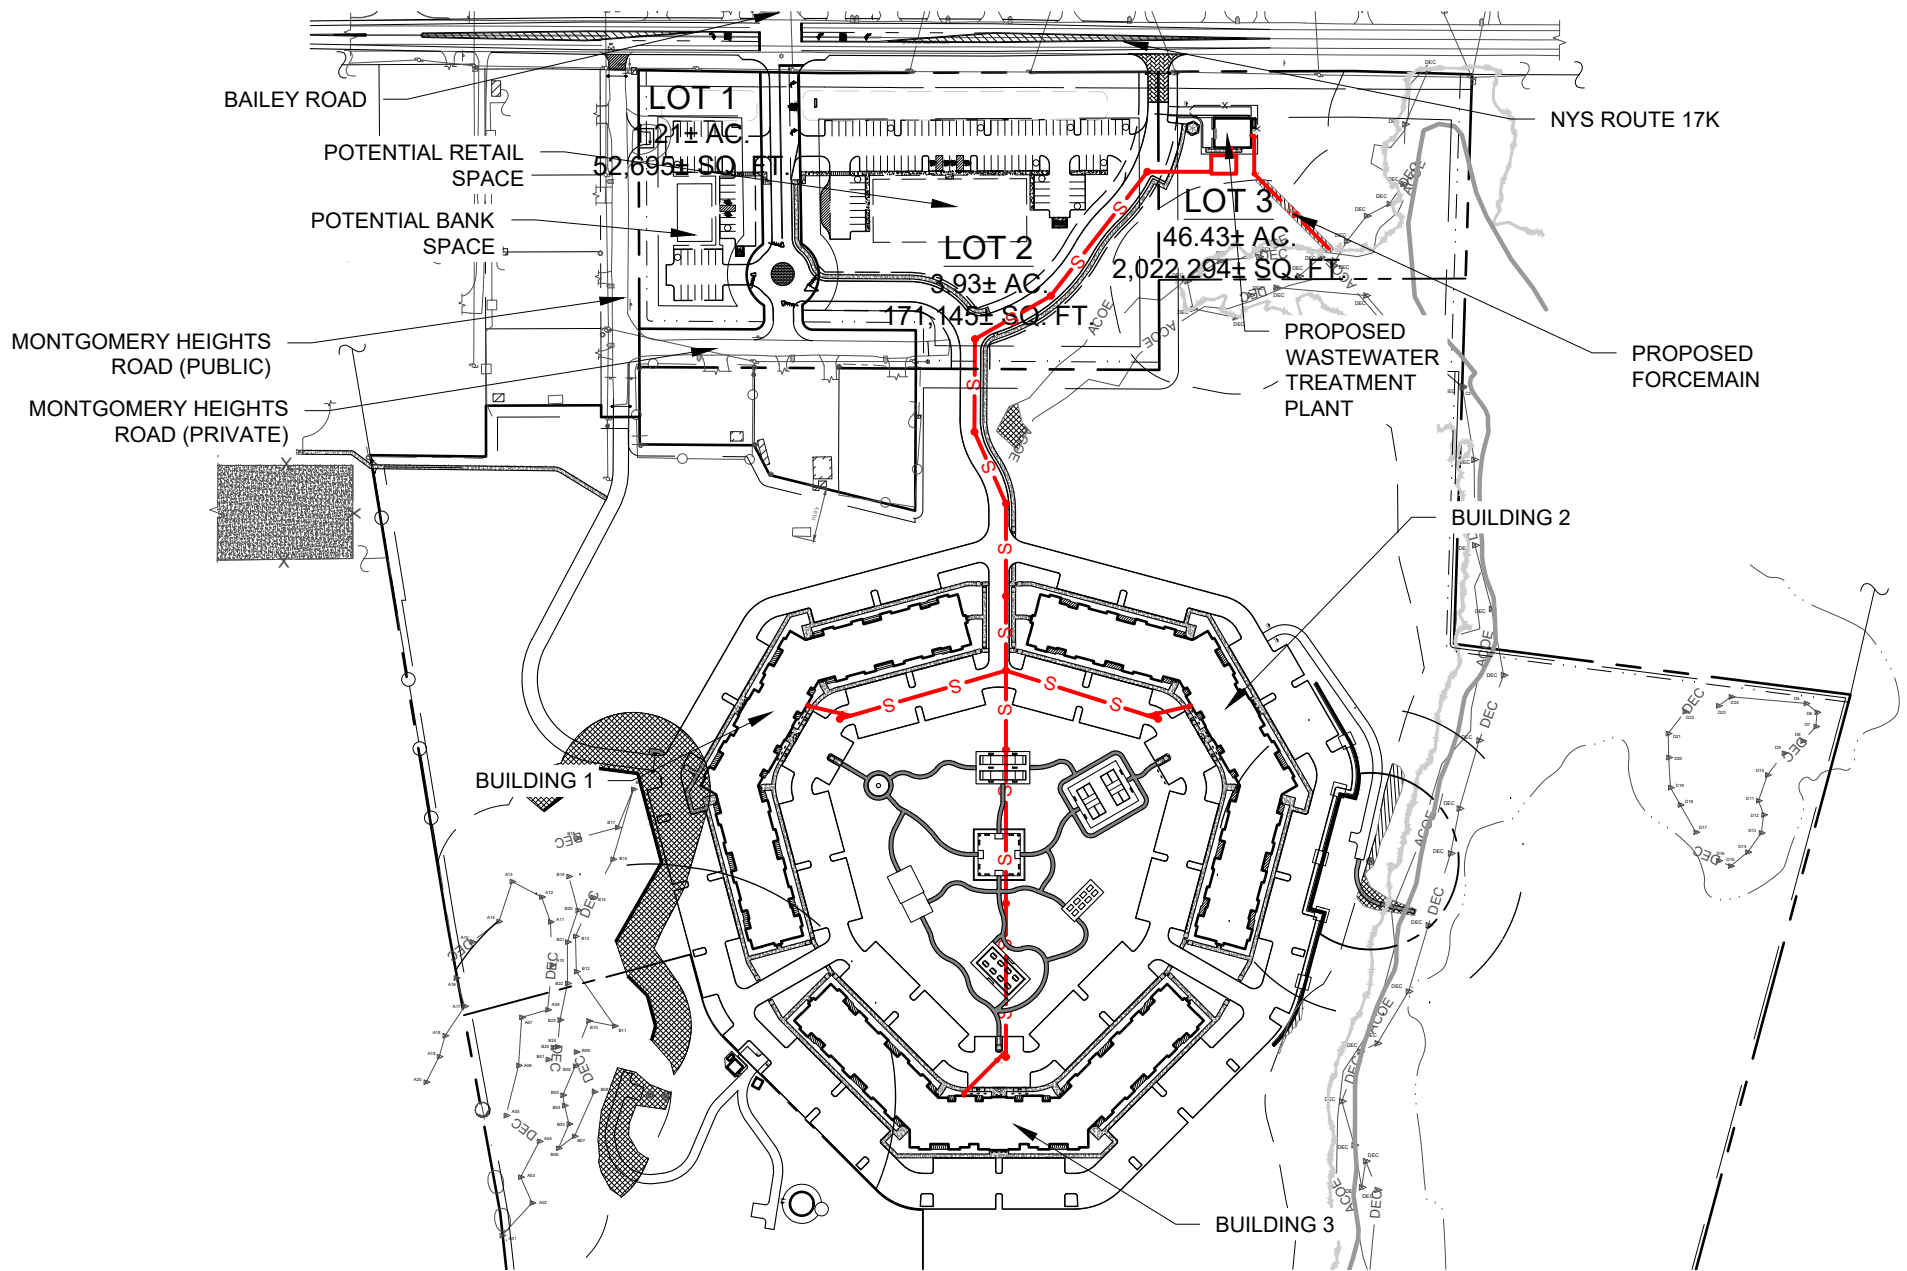

PROPOSED WASTEWATER SYSTEM	SHEFFIELD GARDENS NYS ROUTE 17K TOWN OF MONTGOMERY ORANGE COUNTY, NEW YORK	DATE: 01/22/2024 REV 05/01/2026	JOB # 103.0301	ENGINEERING & SURVEYING PROPERTIES <small>Achieving Successful Results with Innovative Designs</small>	MONTGOMERY OFFICE 71 CLINTON STREET MONTGOMERY, NY 12549 Ph: (845) 457-7727 WWW.EP-PC.COM
		SCALE: 1" = 250'	SHEET # 3.10B		