


Drawing Name: Z:\103.0301 - Sheffield Apartments\103.0301 - Site Plan.dwg Date Printed: May 01, 2026, 11:33am

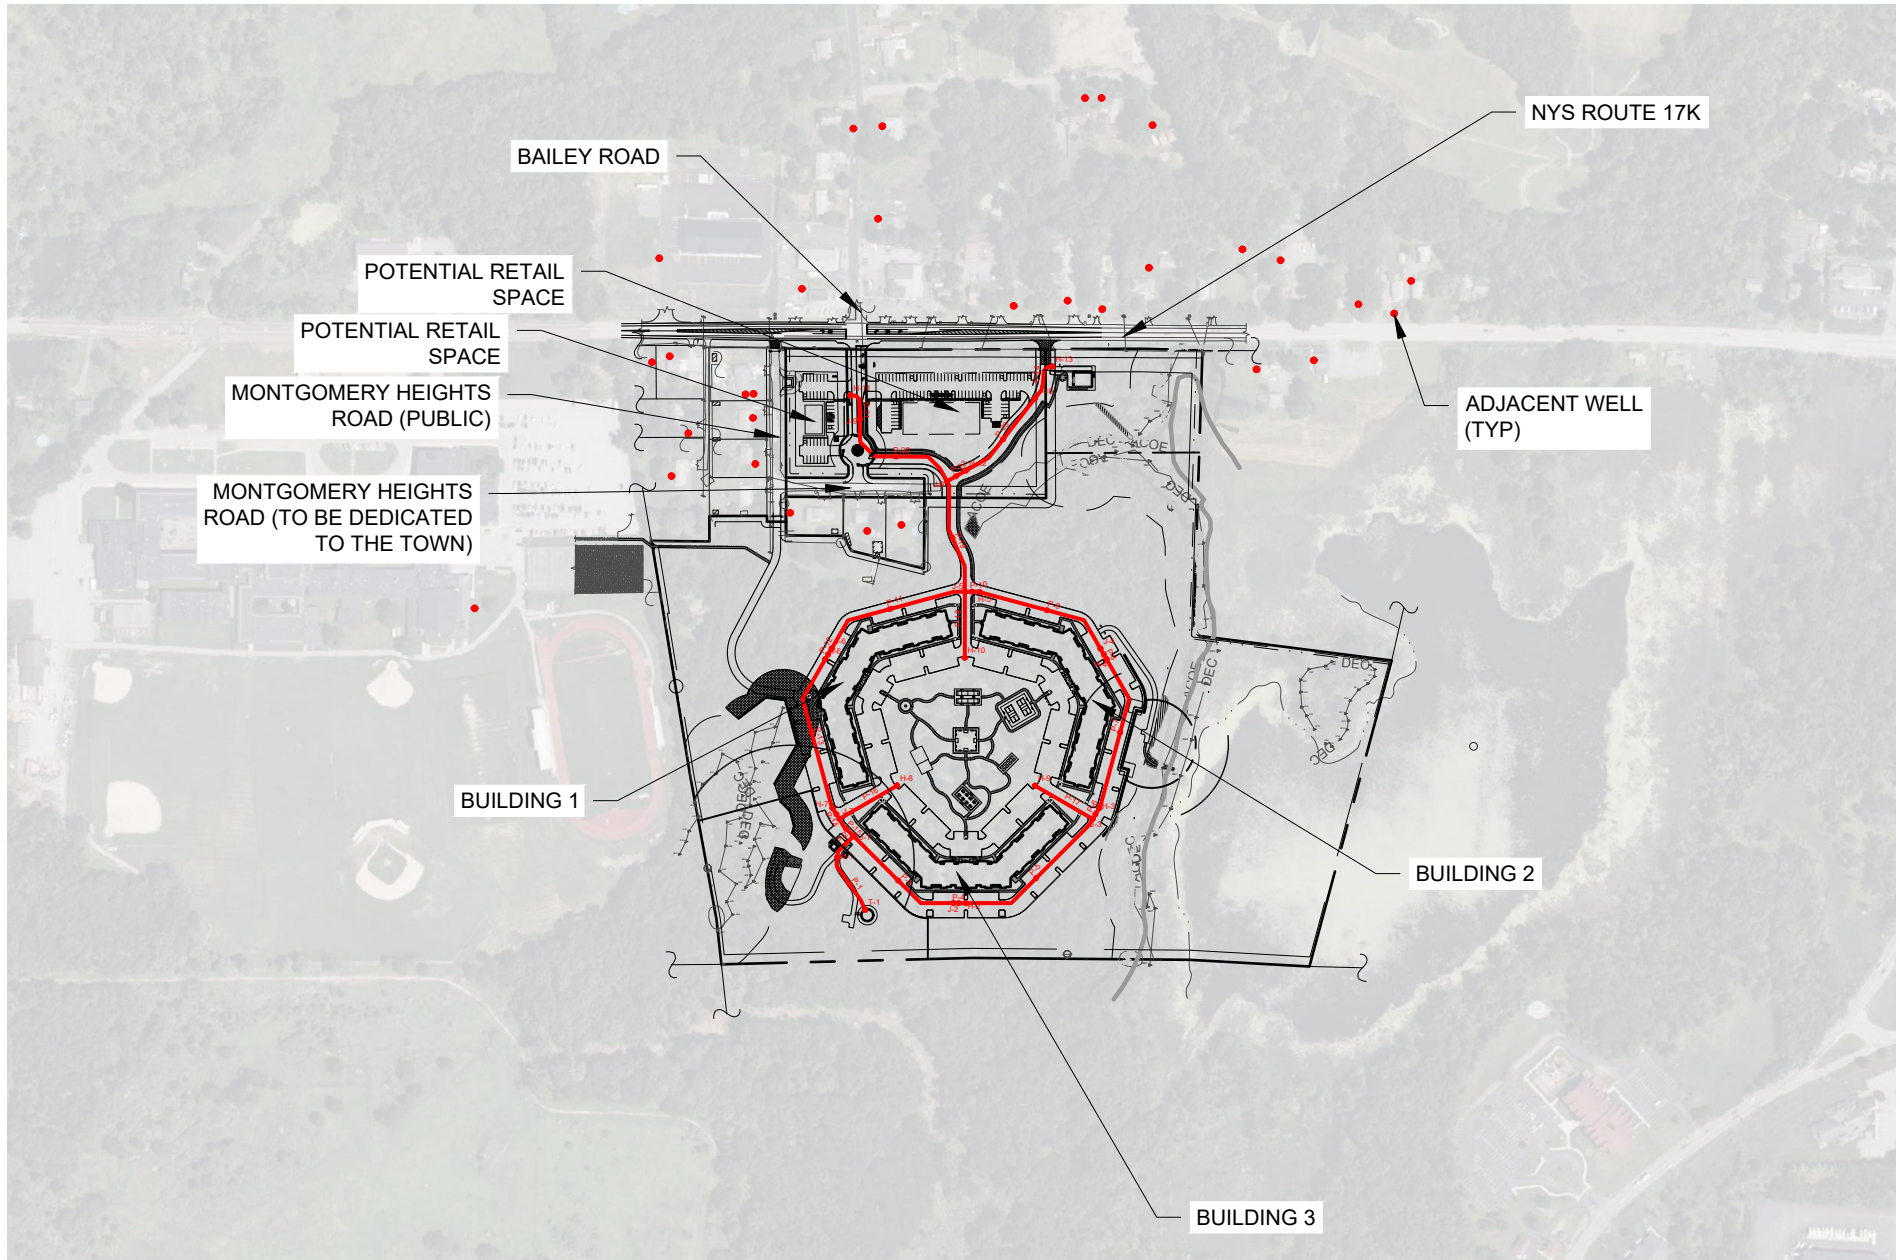

PROPOSED WATER SYSTEM

SHEFFIELD GARDENS
NYS ROUTE 17K
TOWN OF MONTGOMERY
ORANGE COUNTY, NEW YORK

DATE: 01/22/2024
REV 05/01/2026
SCALE: 1" = 500'

JOB # 103.0301
SHEET # 3.3A

ENGINEERING & SURVEYING PROPERTIES
Achieving Successful Results with Innovative Designs

MONTGOMERY OFFICE
71 CLINTON STREET
MONTGOMERY, NY 12549
Ph: (845) 457-7727
WWW.EP-PC.COM