


Drawing Name: Z:\103.0301 - Sheffield Apartments\103.0301 - Site Plan.dwg Date Printed: Nov 25, 2024, 11:29am

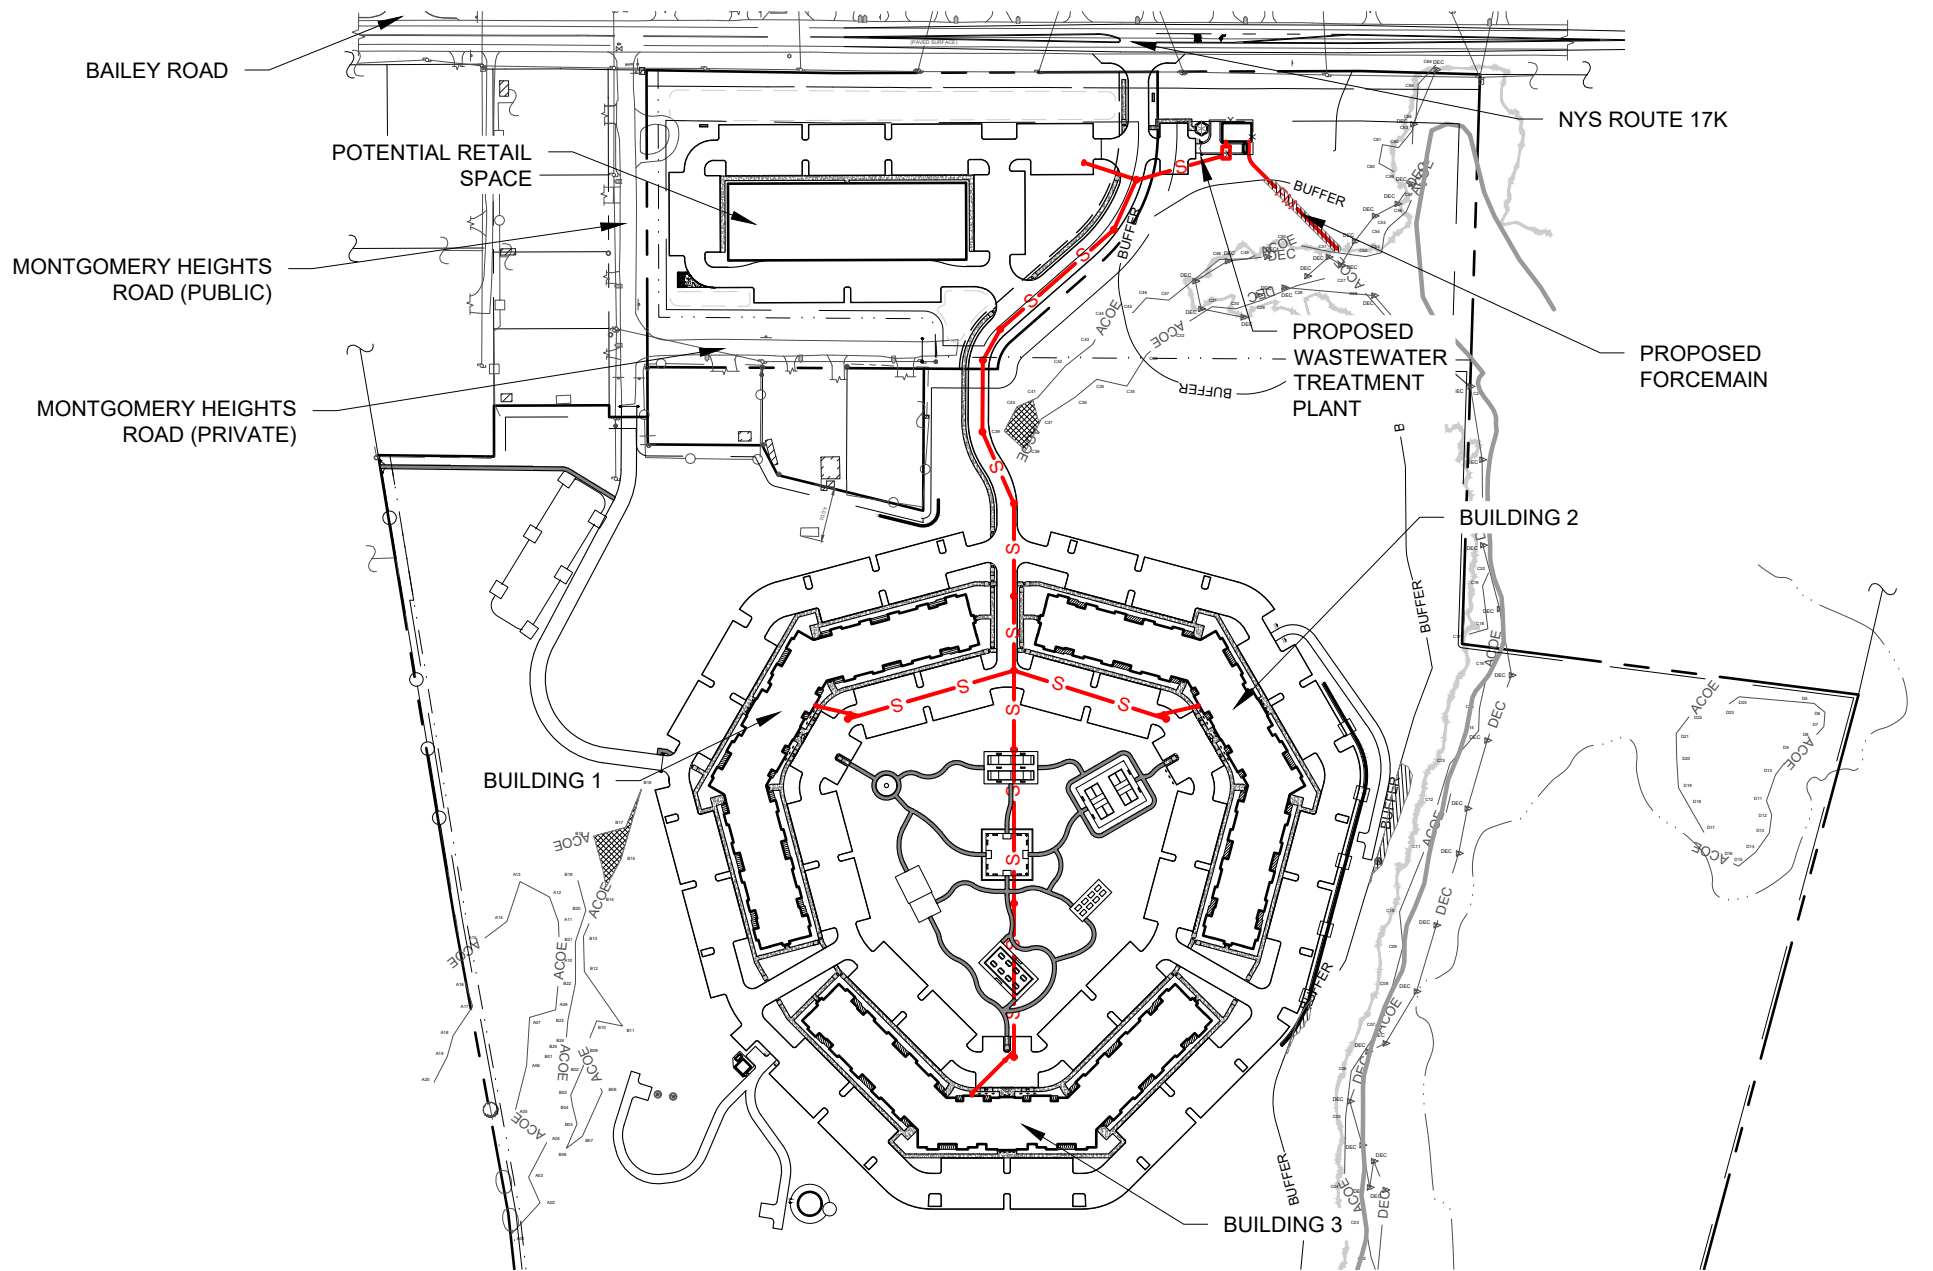

PROPOSED WASTEWATER SYSTEM

SHEFFIELD GARDENS
NYS ROUTE 17K
TOWN OF MONTGOMERY
ORANGE COUNTY, NEW YORK

DATE: 01/22/2024
REV 11/25/2024
SCALE: 1" = 250'

JOB # 103.0301
SHEET # 3.10B

ENGINEERING
& SURVEYING
PROPERTIES
Achieving Successful Results
with Innovative Designs

MONTGOMERY OFFICE
71 CLINTON STREET
MONTGOMERY, NY 12549
Ph: (845) 457-7727
WWW.EP-PC.COM